

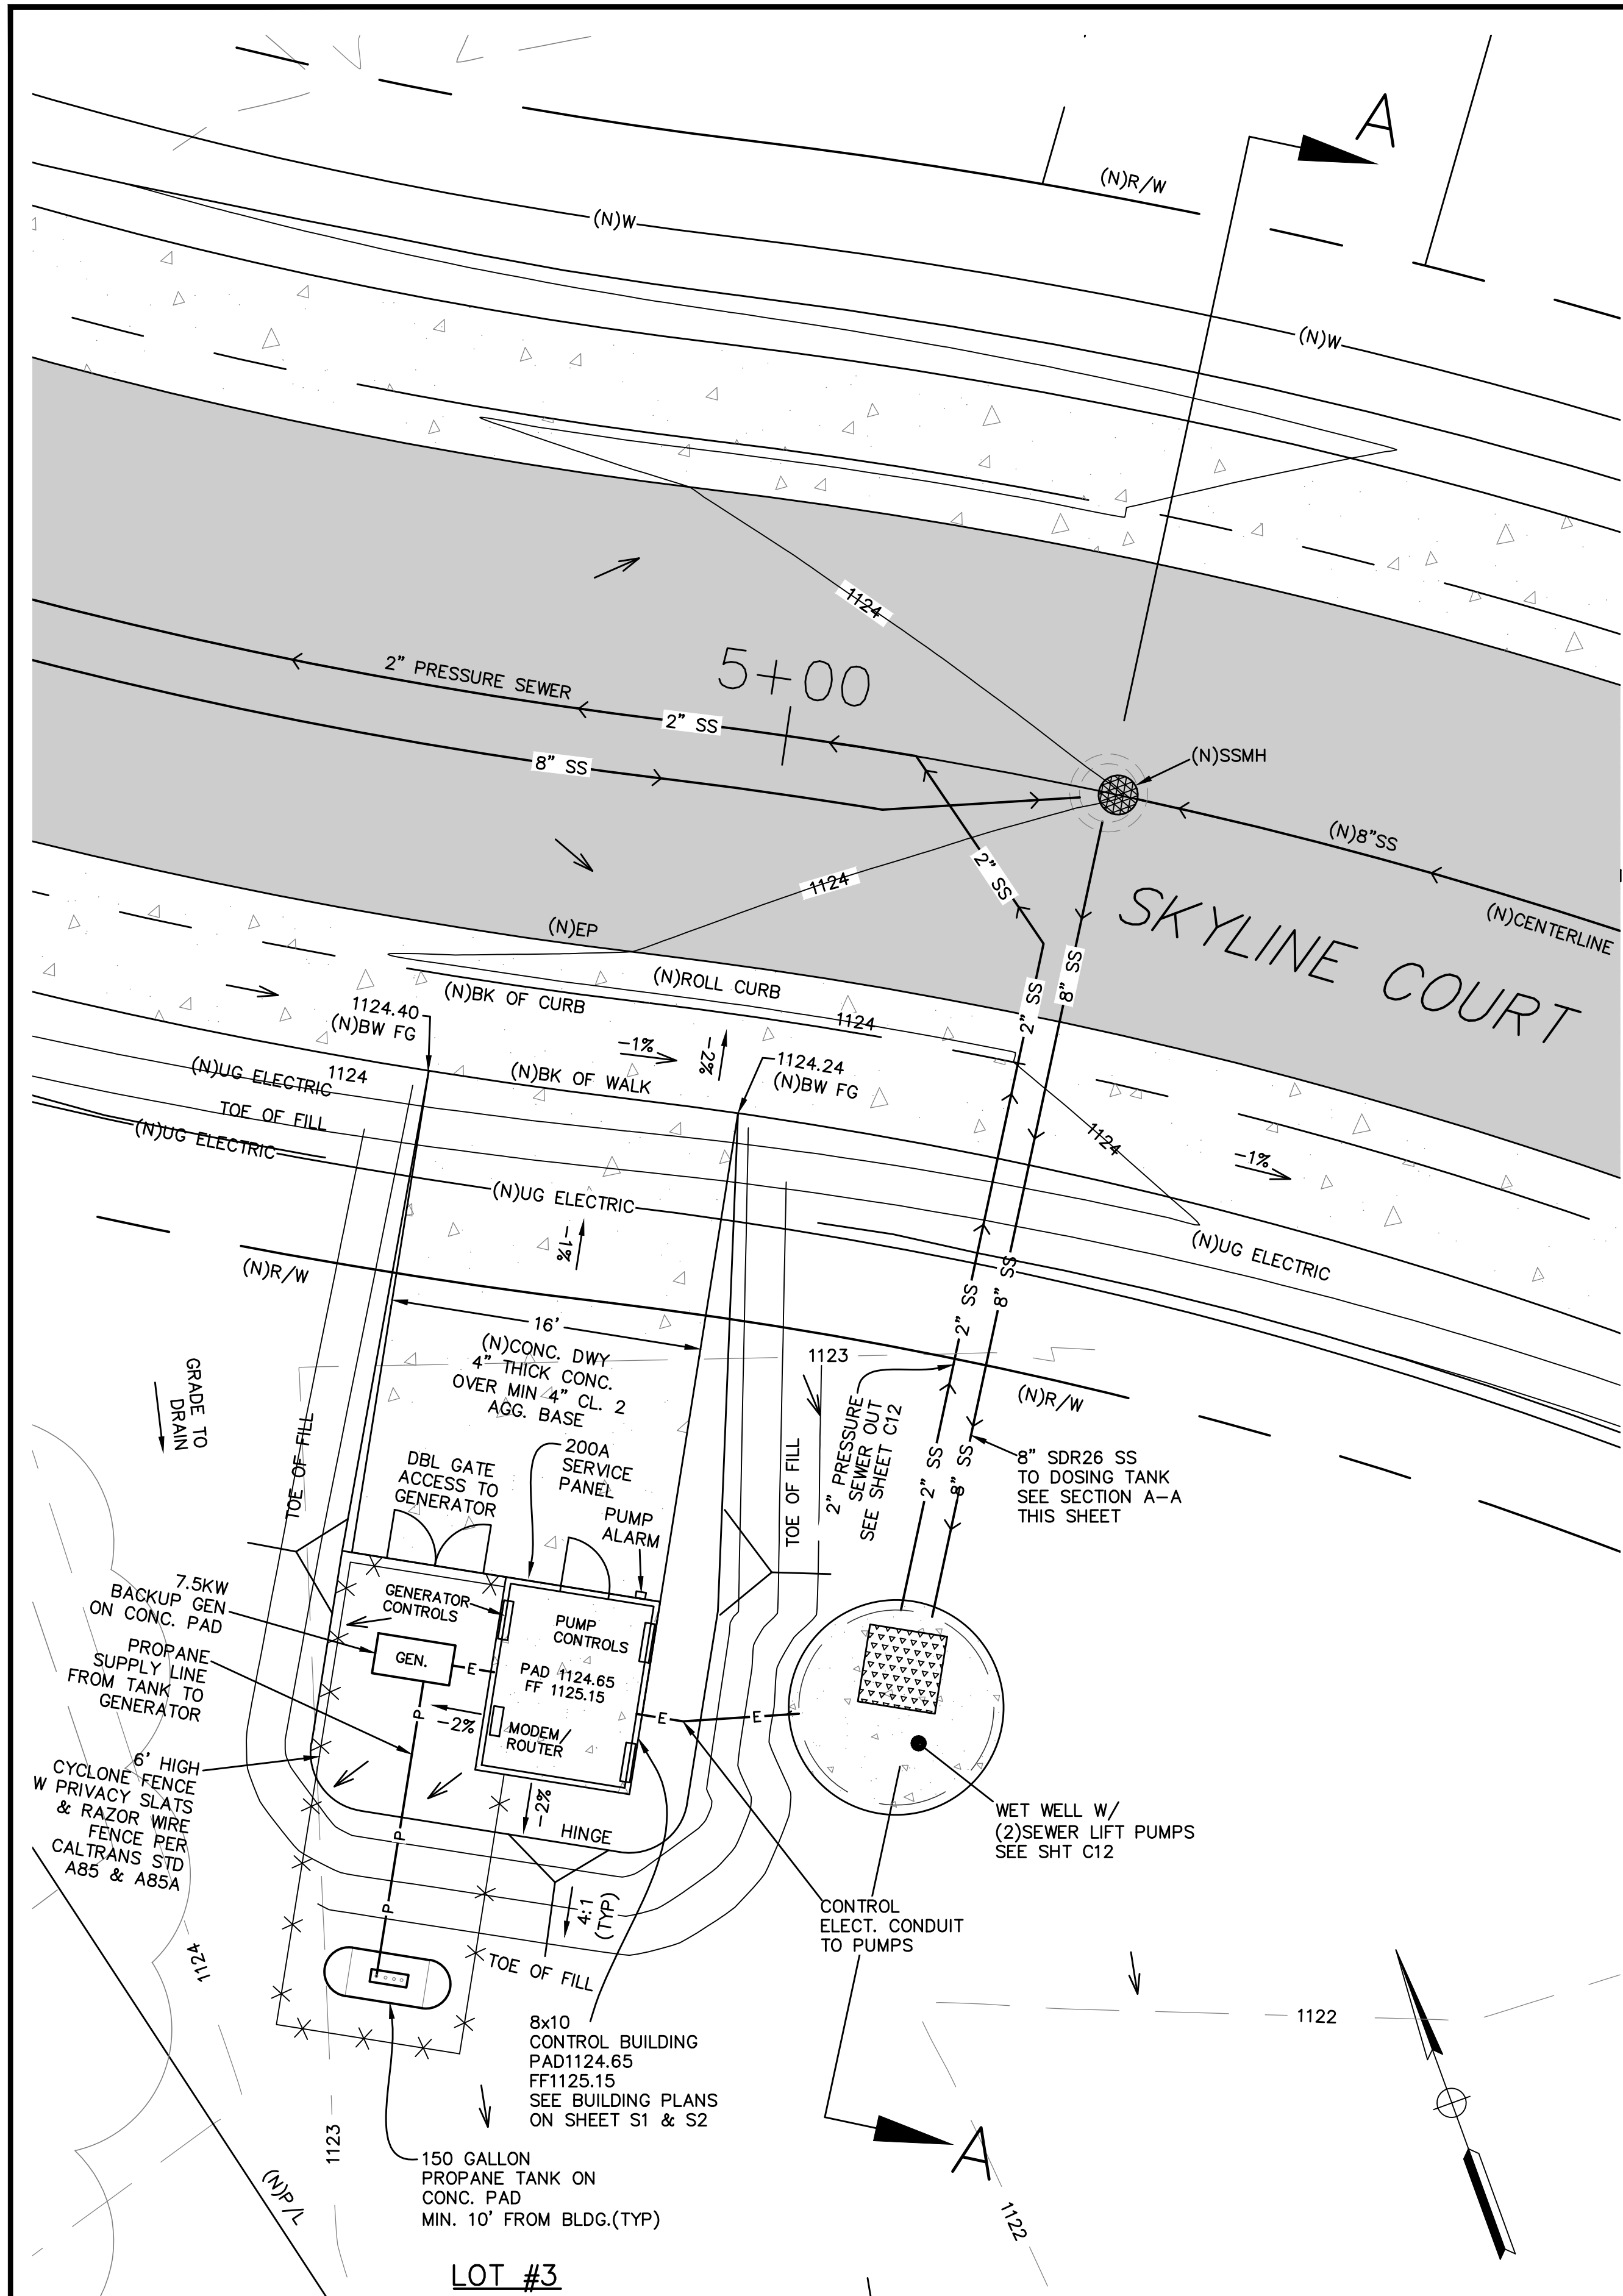


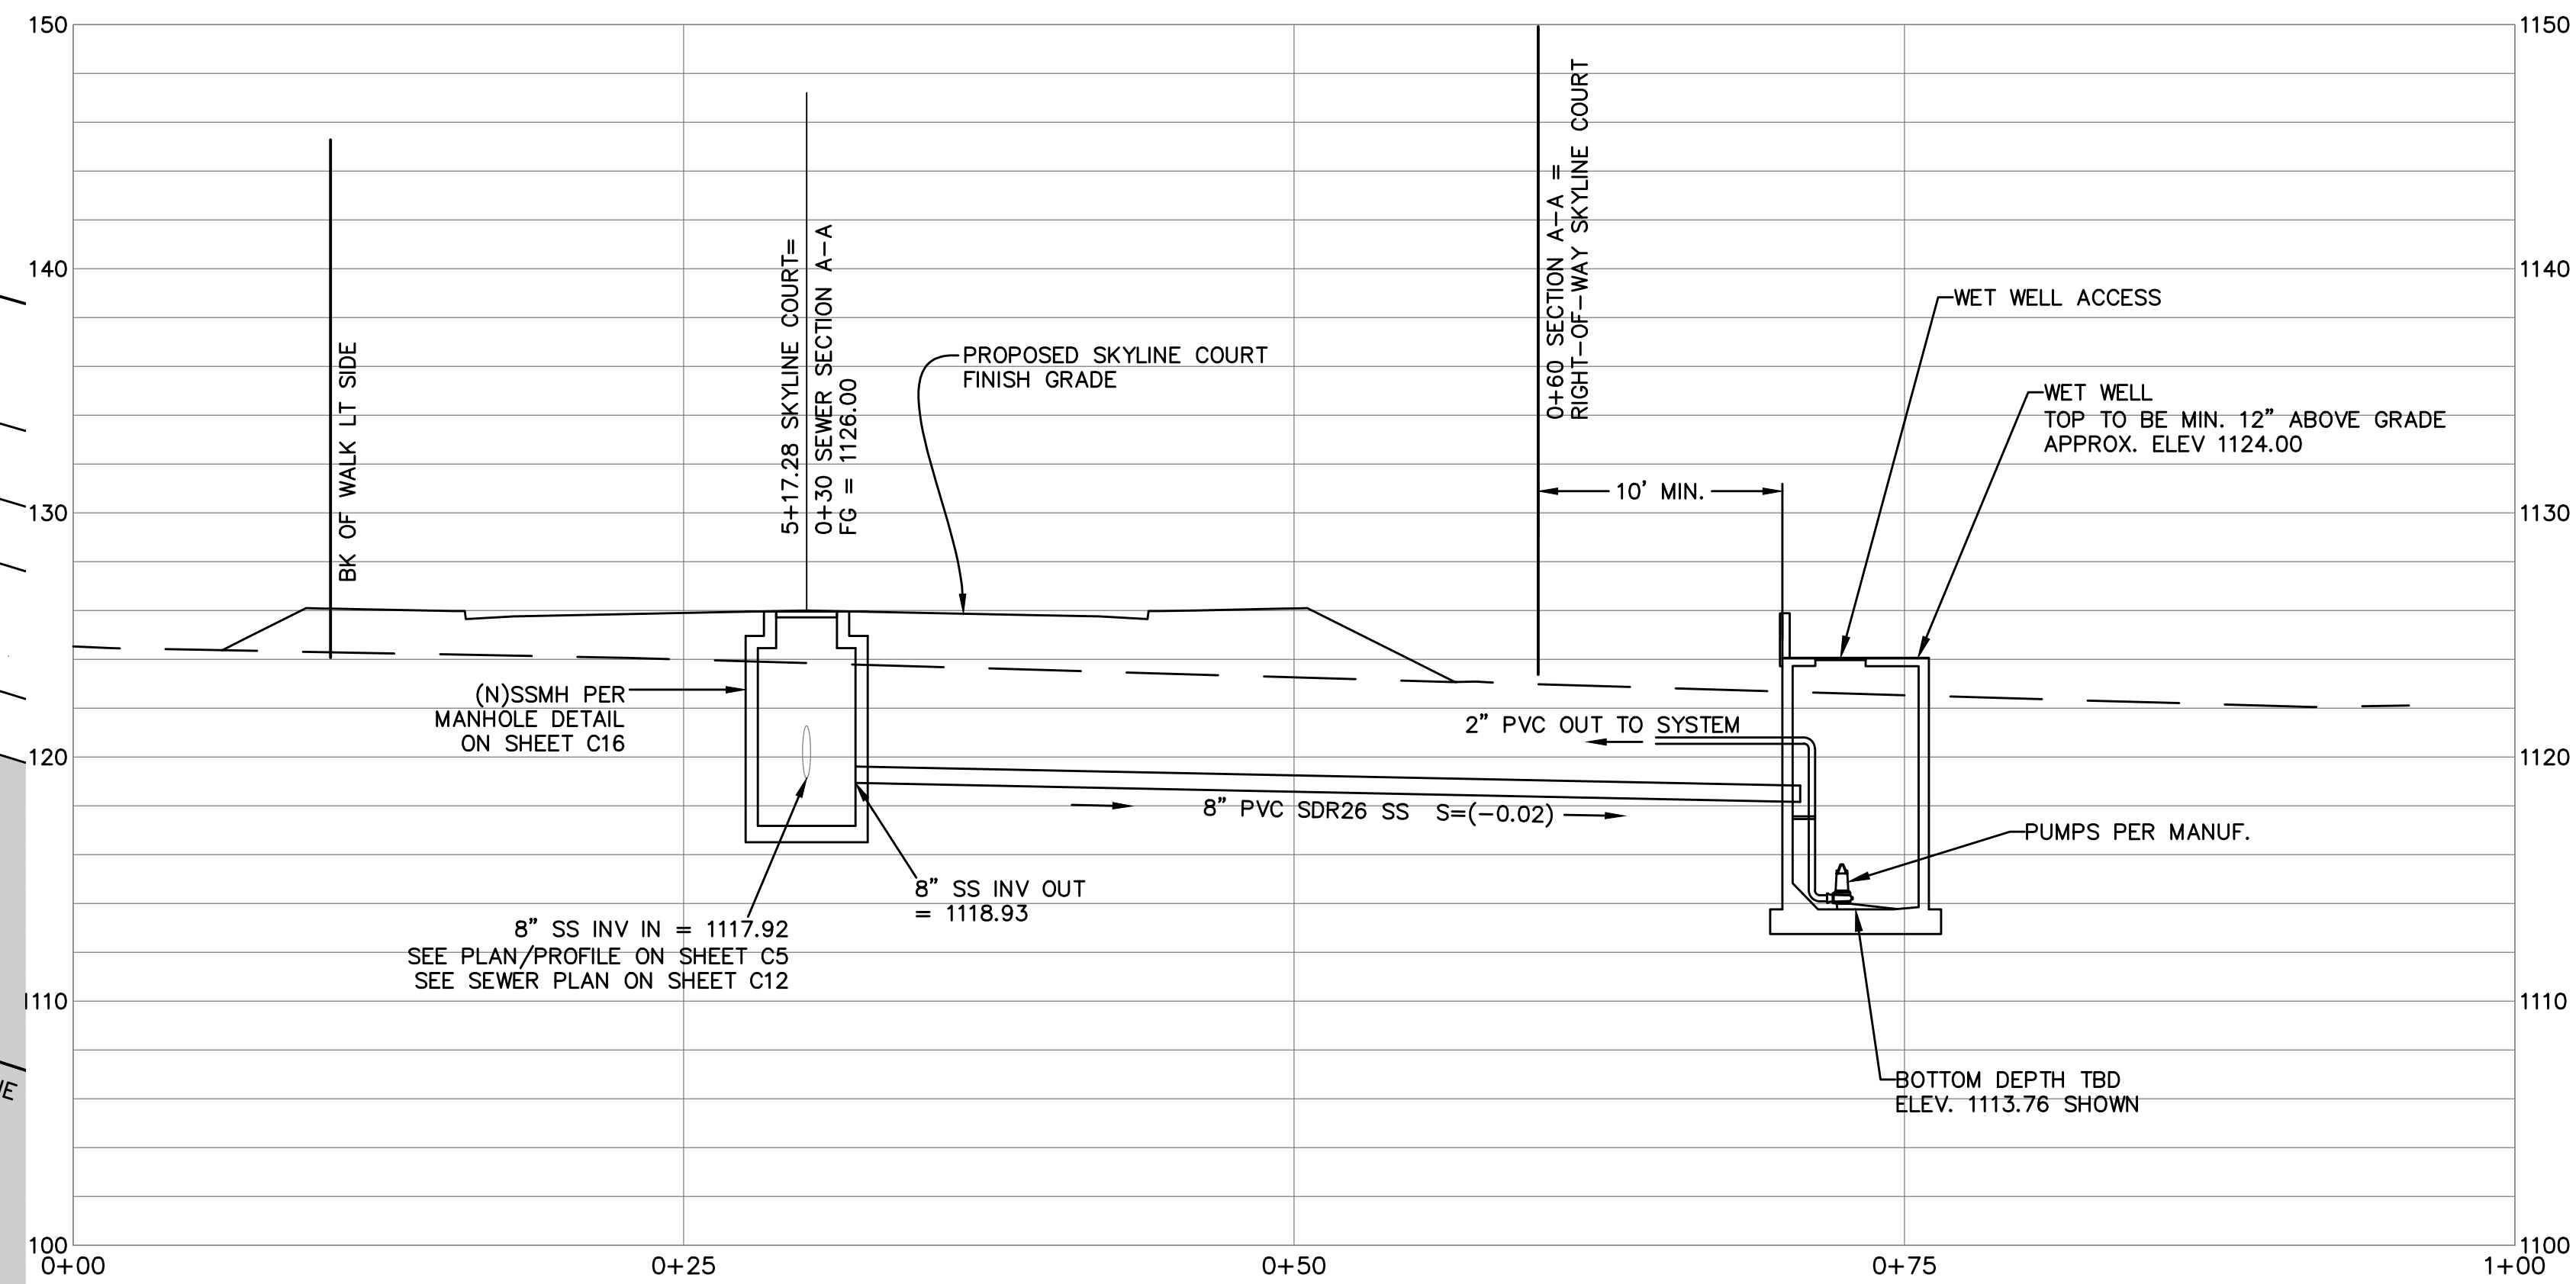


GRADING PLAN
SEWER LIFT STATION

H: 1" = 6'

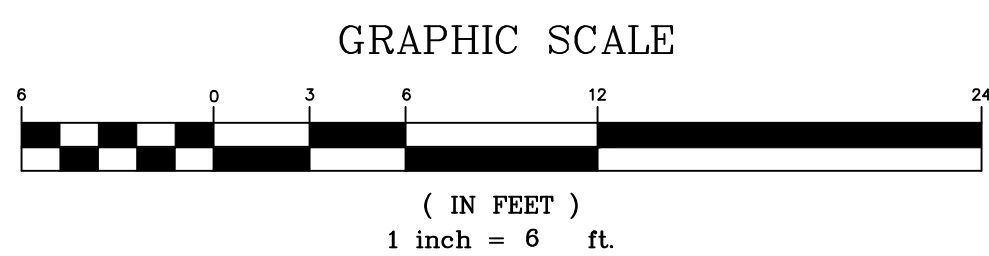

SEWER LINE SECTION A-A

H: 1" = 6'
V: 1" = 6'

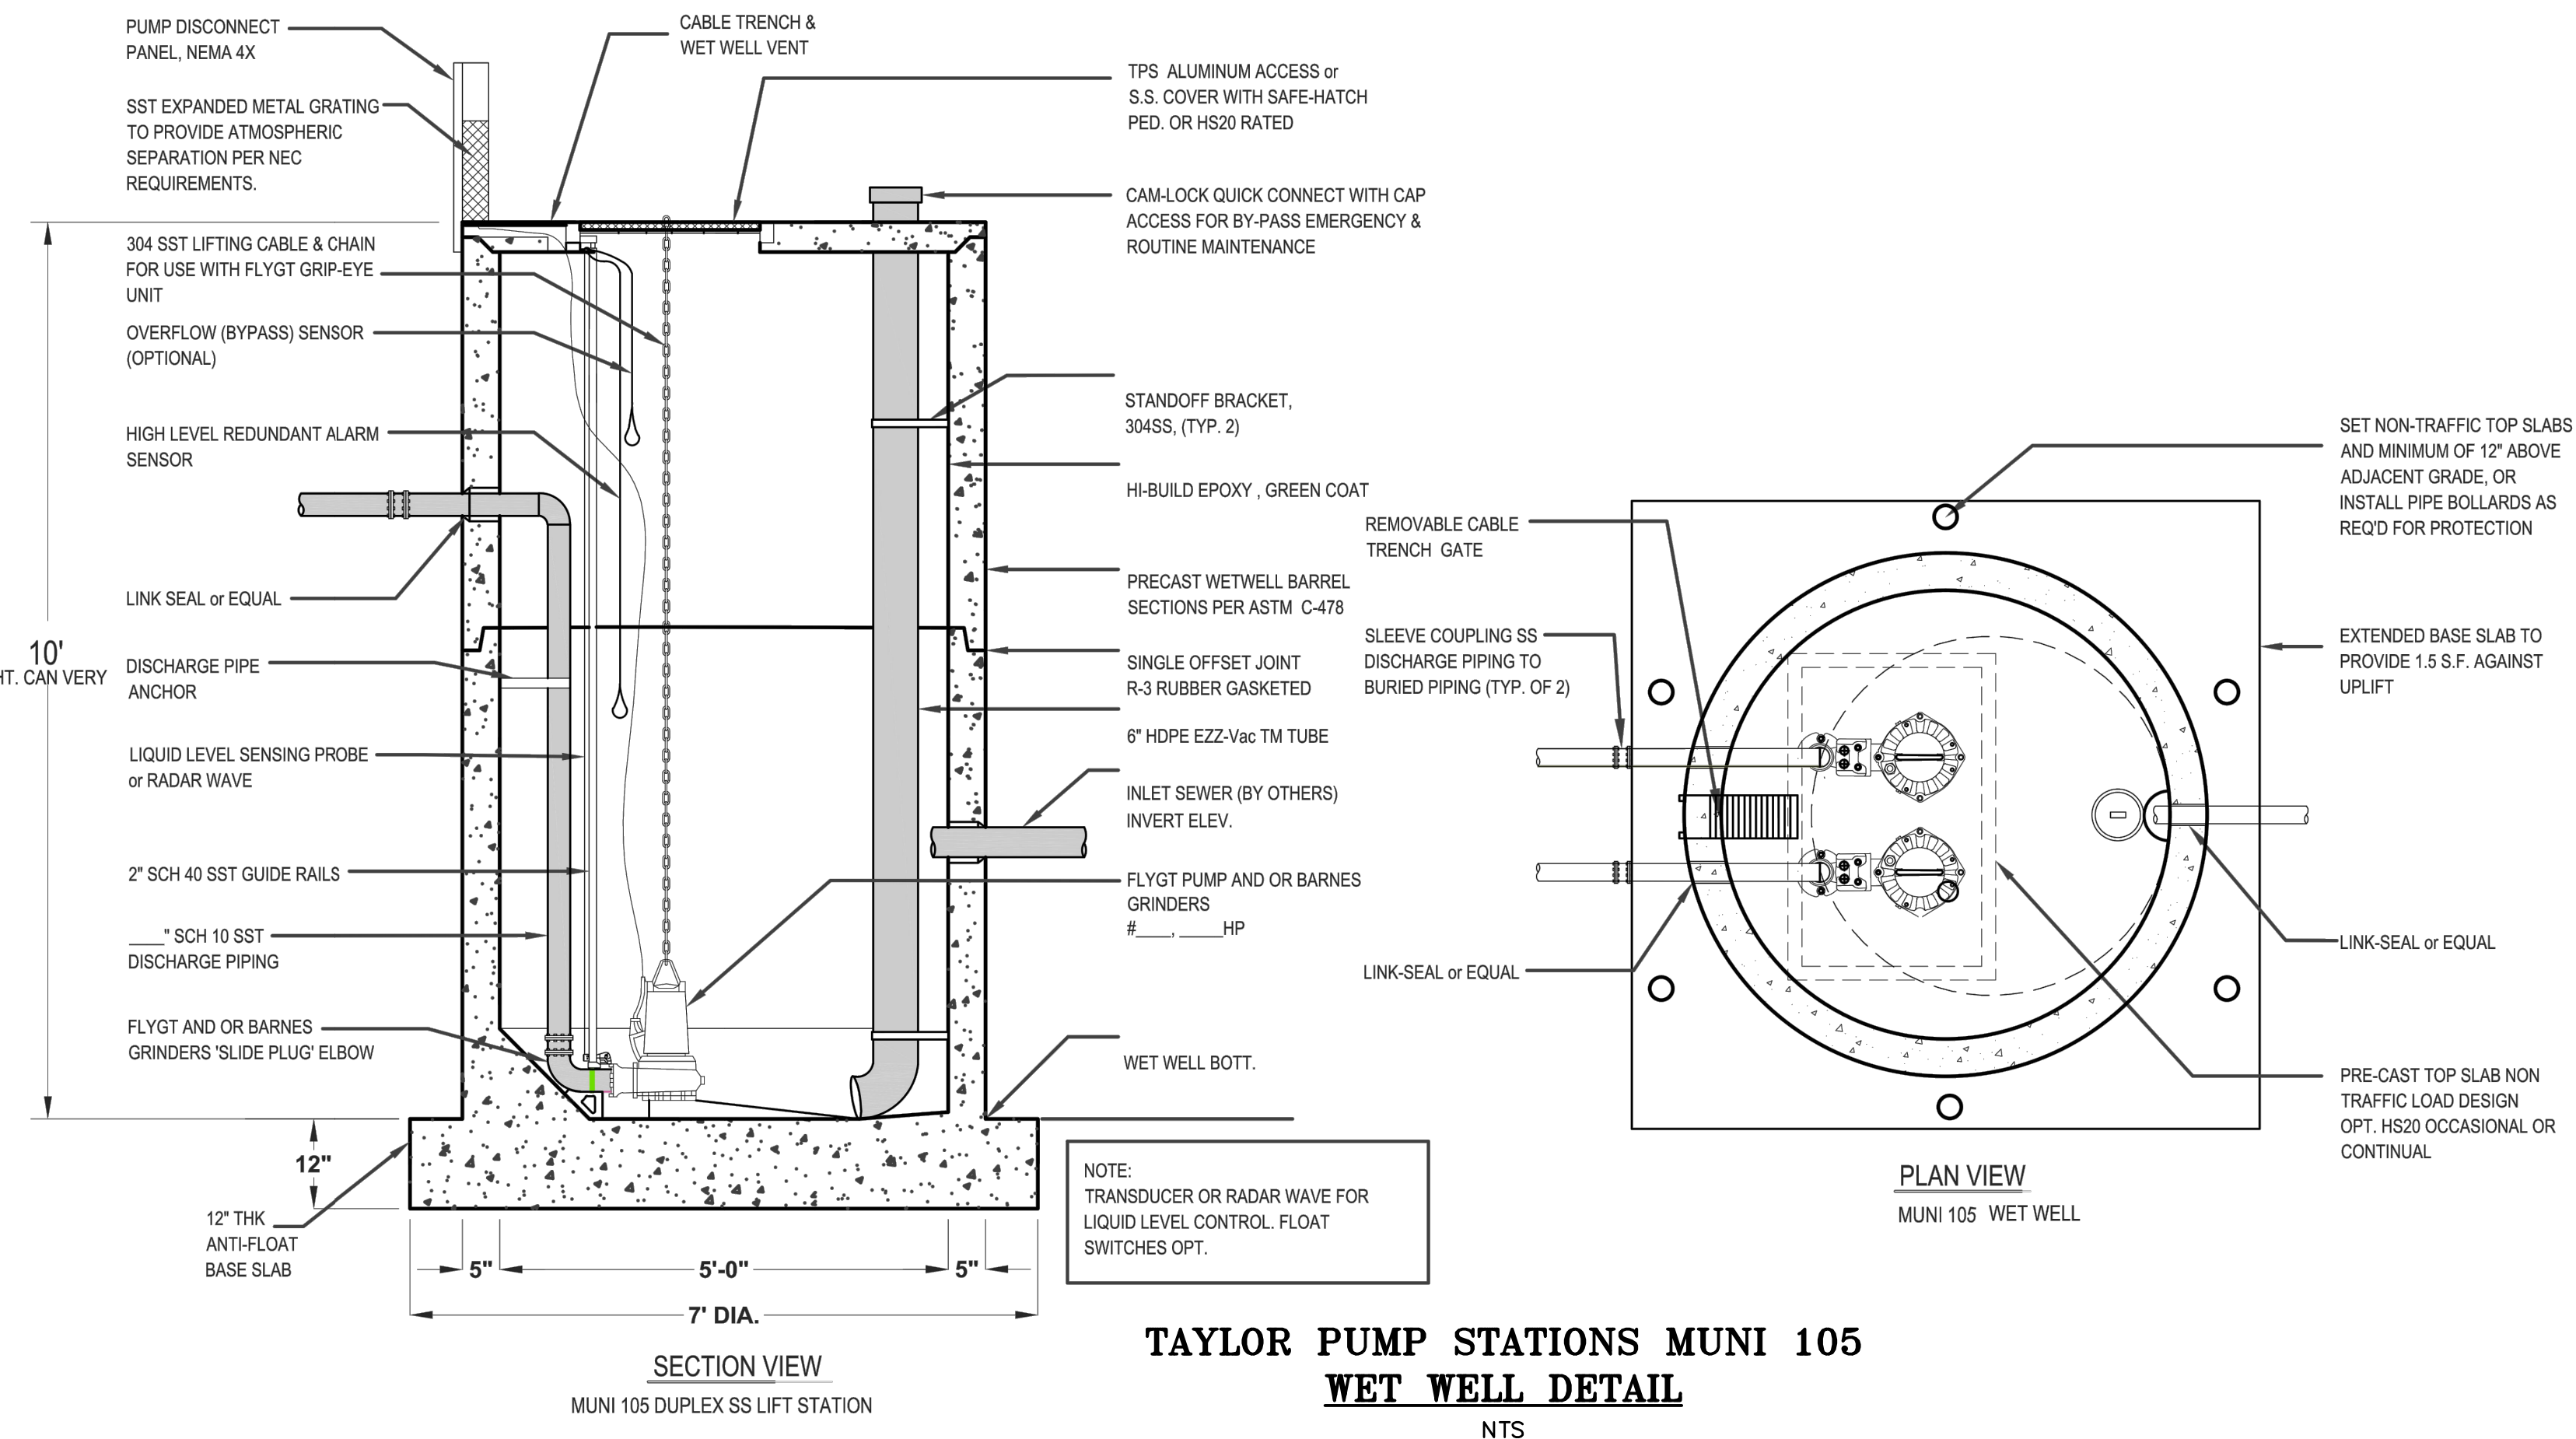

REVISIONS	

PLAN BY: **TVCE**

TRINITY VALLEY CONSULTING ENGINEERS
67 WALNUT WAY
PO BOX 1567
WILLOW CREEK, CA 95573
PHONE (530) 629-3000
FAX (530) 629-3011

SKYLINE DEVELOPMENT

GRADING PLAN
SEWER LIFT STATION

DESIGN BY:	TVCE
DRAWN BY:	SG
CHECKED BY:	FM
DATE:	SEPTEMBER 27, 2023
SCALE:	H: 1" = 20'
PROJECT NO:	236.10

C10